



NOTE: FIRE PROTECTION DETAILS SHOWN HEREIN ARE INTENDED TO REDUCE THE RISK OF FIRE SPREAD IN THE EVENT OF A CATASTROPHIC CABLE JOINT FAILURE. HOWEVER THERE IS NO GUARANTEE THAT THE RISK OF FIRE DAMAGE TO ADJACENT CABLES WILL BE ELIMINATED.

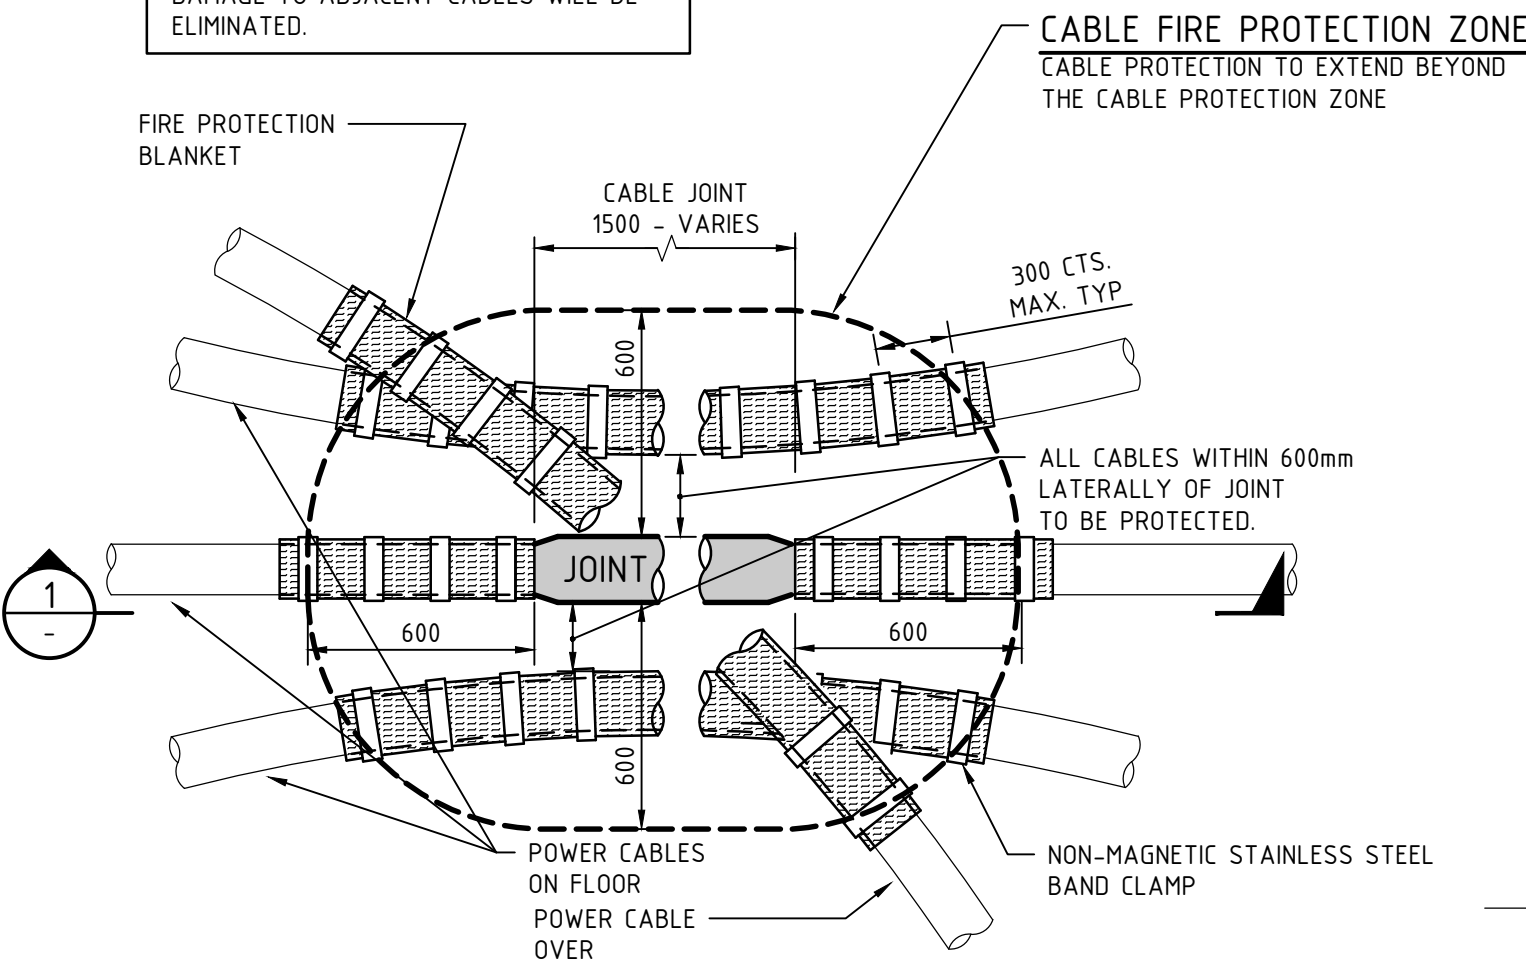


PLAN AT CABLE ON FLOOR

NTS

- NOTES:**
1. CABLE PROTECTION ALSO APPLIES TO CABLES BELOW AND ADJACENT TO JOINT
 2. CABLE BLANKET PROTECTION ALSO APPLIES TO SECONDARY CABLES
 3. REFER TO 252098, 252099, 252100 AND 252111
 4. NOTIFY CABLE RATINGS SECTION THAT CABLES ARE COVERED - ENTRY INTO GIS IS REQUIRED.
 5. FOR STANDARD DESIGN AND SAFETY NOTES REFER TO TRIM REFERENCE D20/295304

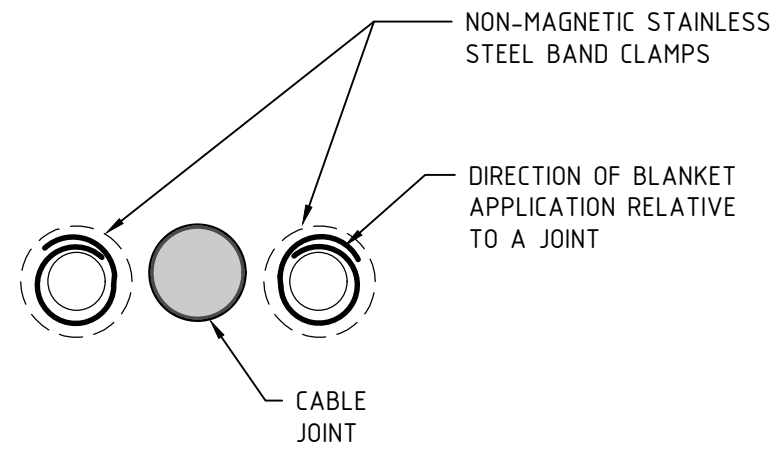

1a DETAIL
N.T.S

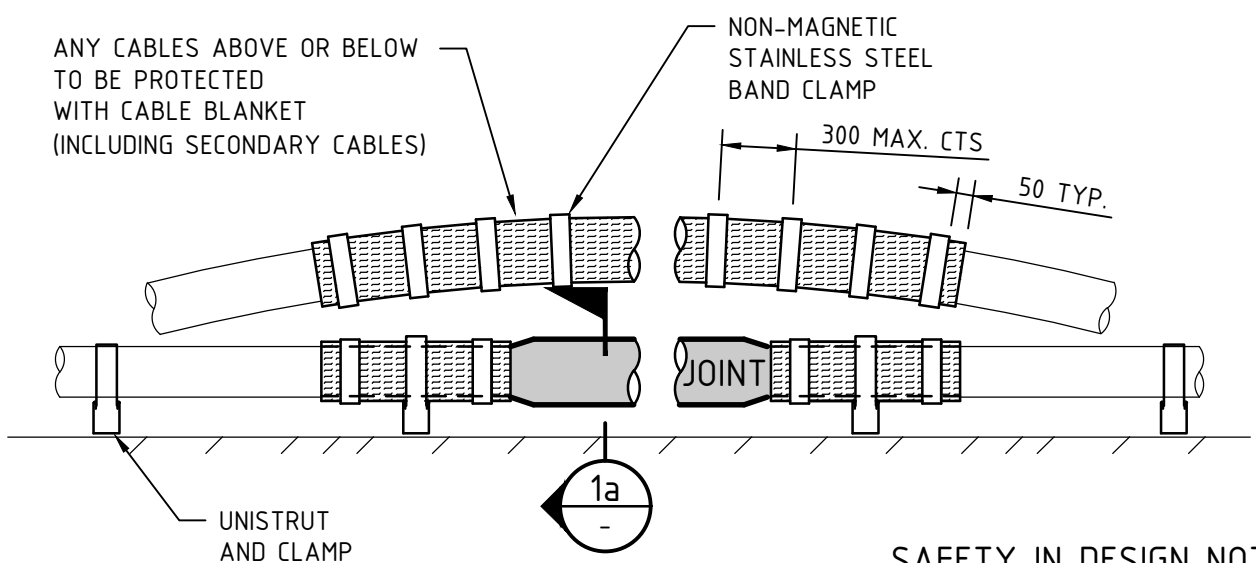

1 SECTION
N.T.S

SAFETY IN DESIGN NOTES
THIS IS A STANDARD DRAWING SO SITE SPECIFIC SAFETY ISSUES HAVE NOT BEEN CONSIDERED. SITE SPECIFIC ISSUES SHALL BE CONSIDERED AND DOCUMENTED BY THE PROJECT DESIGN TEAM. REFER TO THE SITE SPECIFIC SAFETY IN DESIGN REPORT FOR THE PROJECT PRIOR TO USING THIS DRAWING.

AMENDMENTS						
AMD	DATE	DESCRIPTION	DRAWN BY	DESIGNED BY	CHECKED BY	APPROVED BY
0	29.06.20	CONSTRUCTION ISSUE	J.ABDILLA	T.VELONAS	J.METTI	K.GALLEN
1	16.09.20	TRIM REFERENCE REVISED	J.ABDILLA	T.VELONAS	J.METTI	K.GALLEN



SCALE	AS SHOWN
DESIGNED	TASS VELONAS
DRAWN	JOSEPH ABDILLA
CHECKED	JOE METTI
APPROVED	KATINA GALLEN
DATE	06.07.20
TRIM REF	2019/26353

**CABLE BLANKET FIRE PROTECTION
POWER AND SECONDARY CABLES
NEAR CABLE JOINTS
SECTION AT CABLES ON FLOOR
SHEET 4**

ISSUED FOR
CONSTRUCTION

PROJECT NUMBER	SJ-00313
----------------	----------

SIZE	DRAWING No	SHEET	AMD
A3	252101	1	1

CAD DRAWING
DO NOT MANUALLY AMEND
AMENDMENTS